


**Electrical First Floor Plan**  
Scale 1/4" = 1'-0"

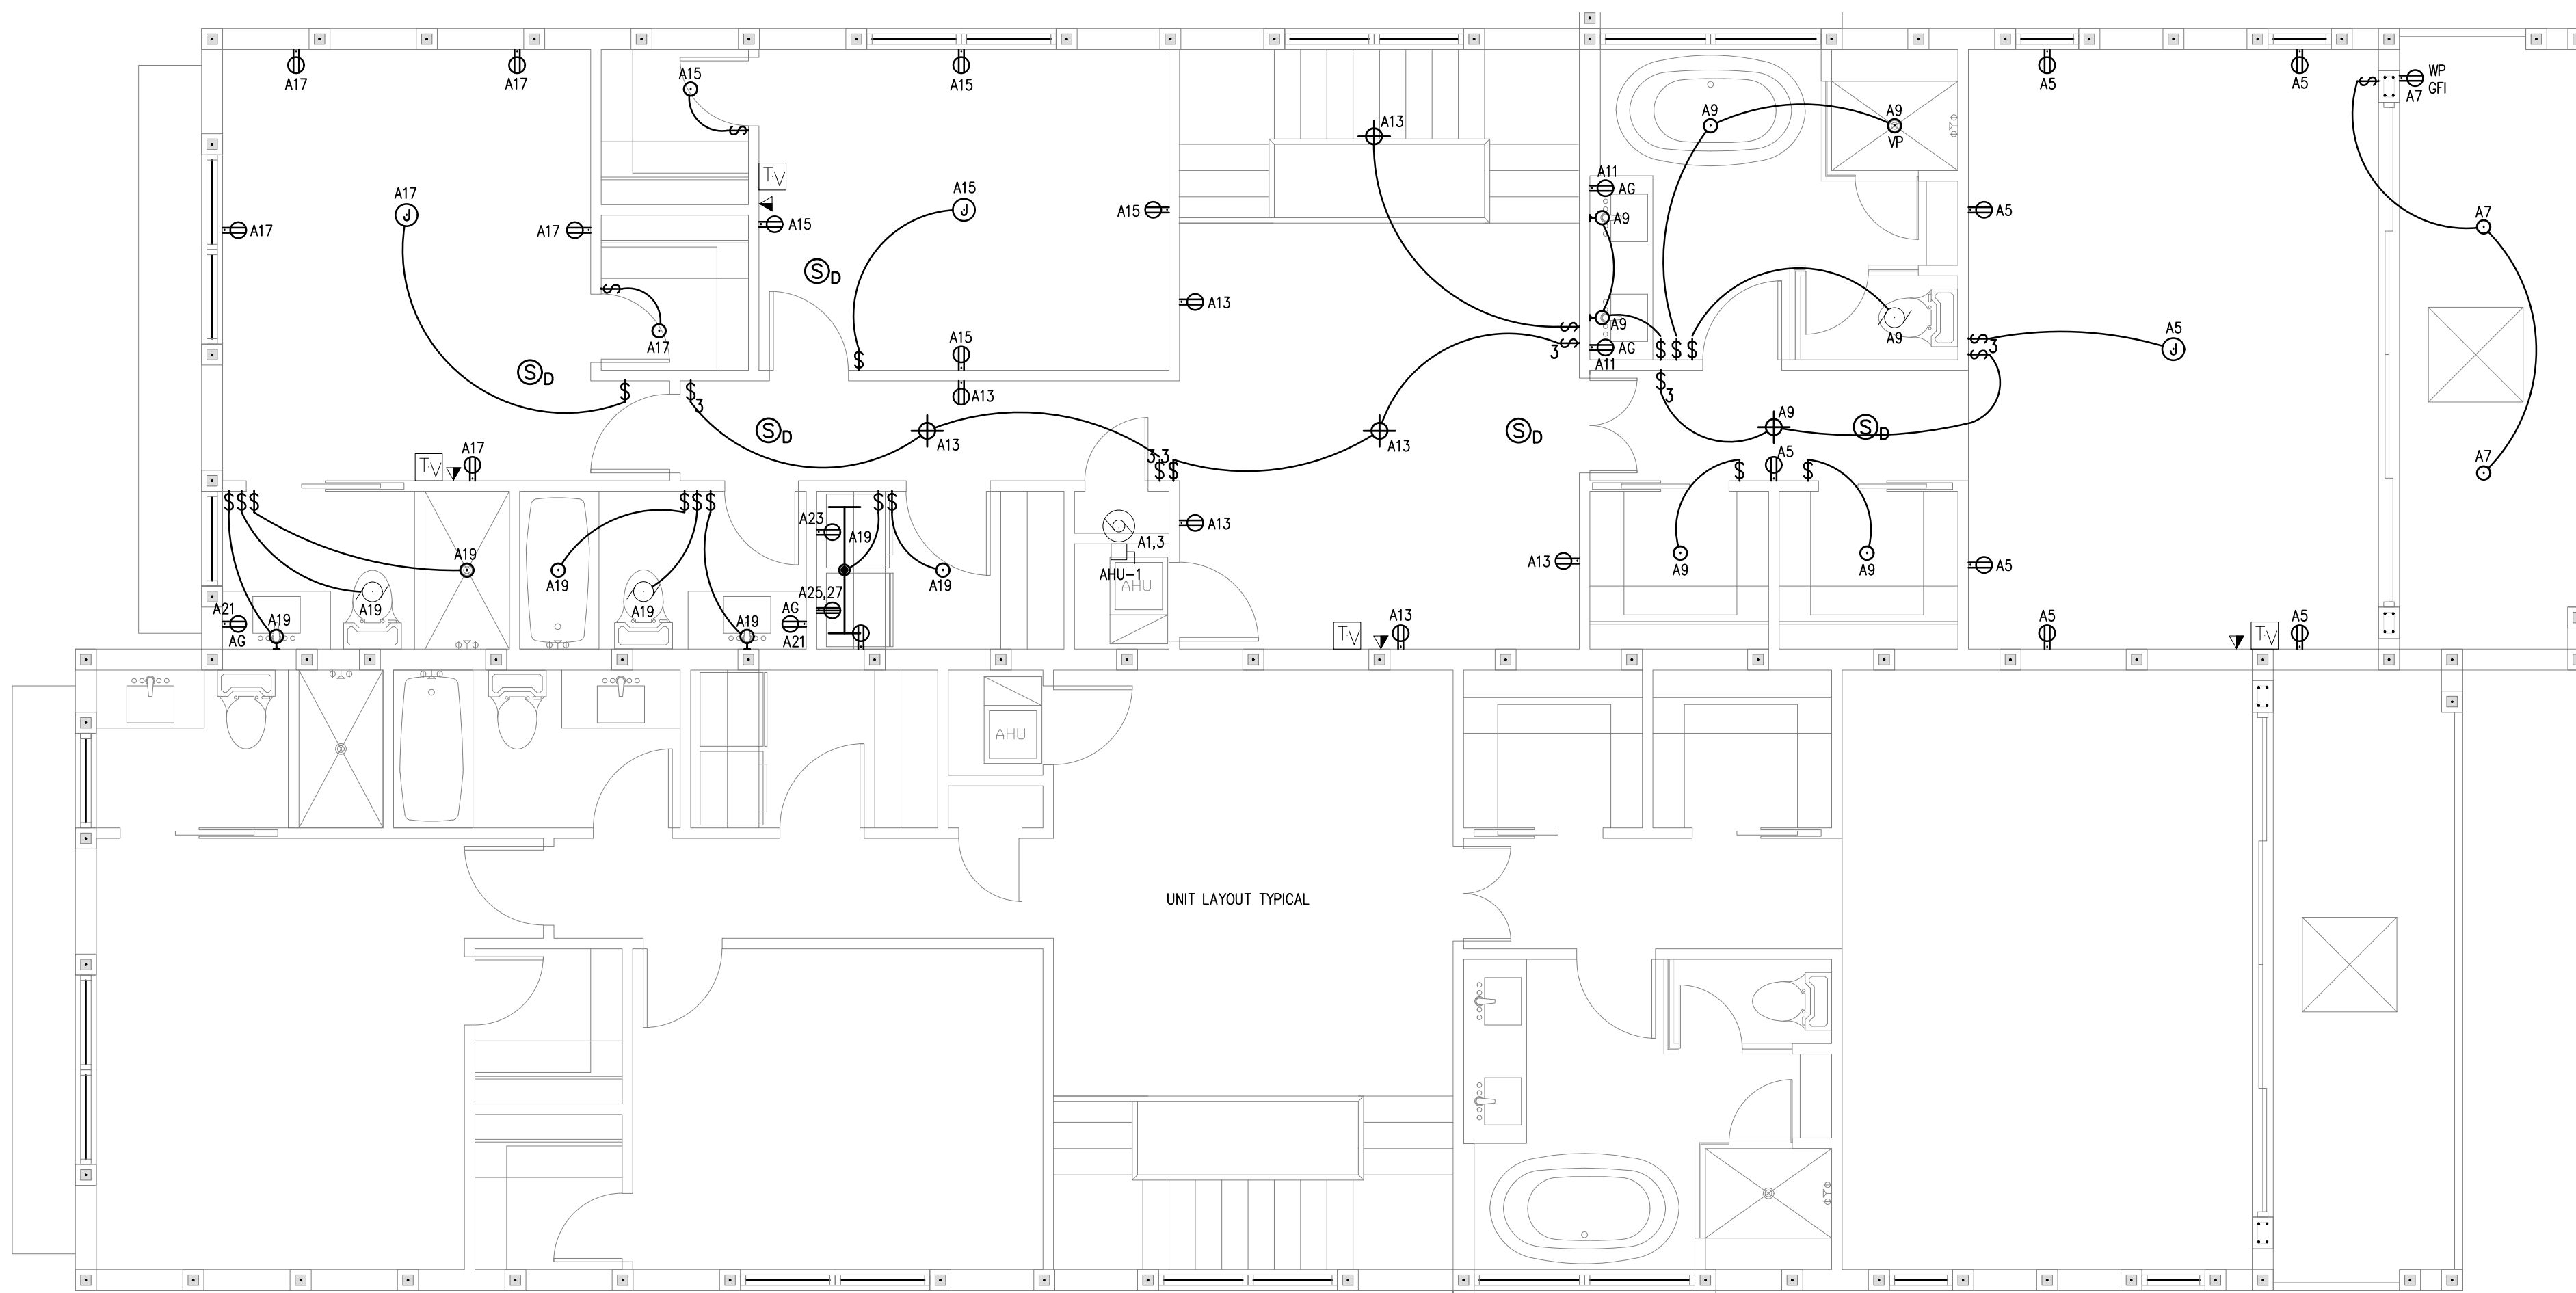

**Electrical Second Floor Plan**  
Scale 1/4" = 1'-0"